

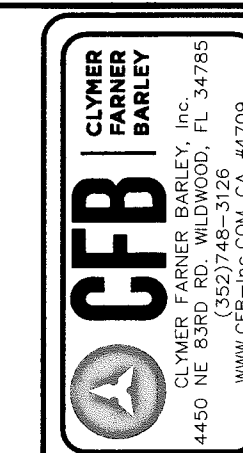


SPECIFIC PURPOSE SURVEY

THE PURPOSE OF THIS SURVEY IS TO SHOW SURVEY DATA AND SITE FEATURES IN THOSE AREAS AS SPECIFIED BY THE CLIENT AND SHOWN HEREON.

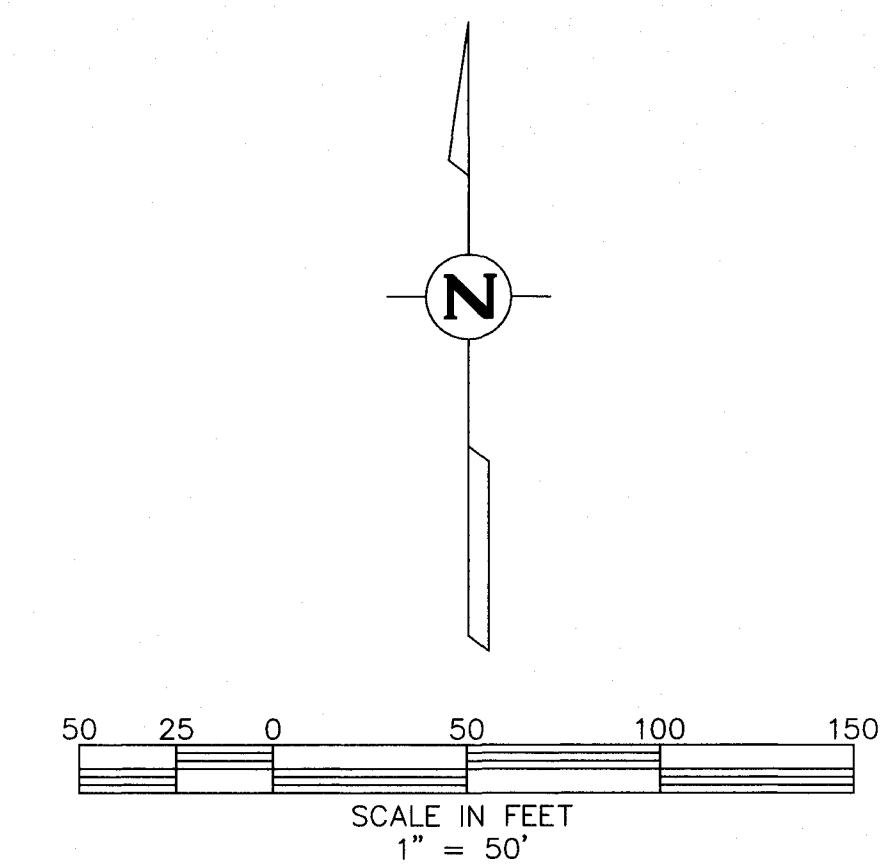


DATE	
REVISIONS	
CITY OF WILDWOOD	DATE OF SURVEY 7/27/2022
CITY OF WILDWOOD	FIELD BOOK K22-14749
DRAWING DATE 8/2/2022	CHECKED BY KAJ
DRAWN BY JF	SCALE MILLIUM-PARK LOCATES-2022.dwg
W/CD FILE	

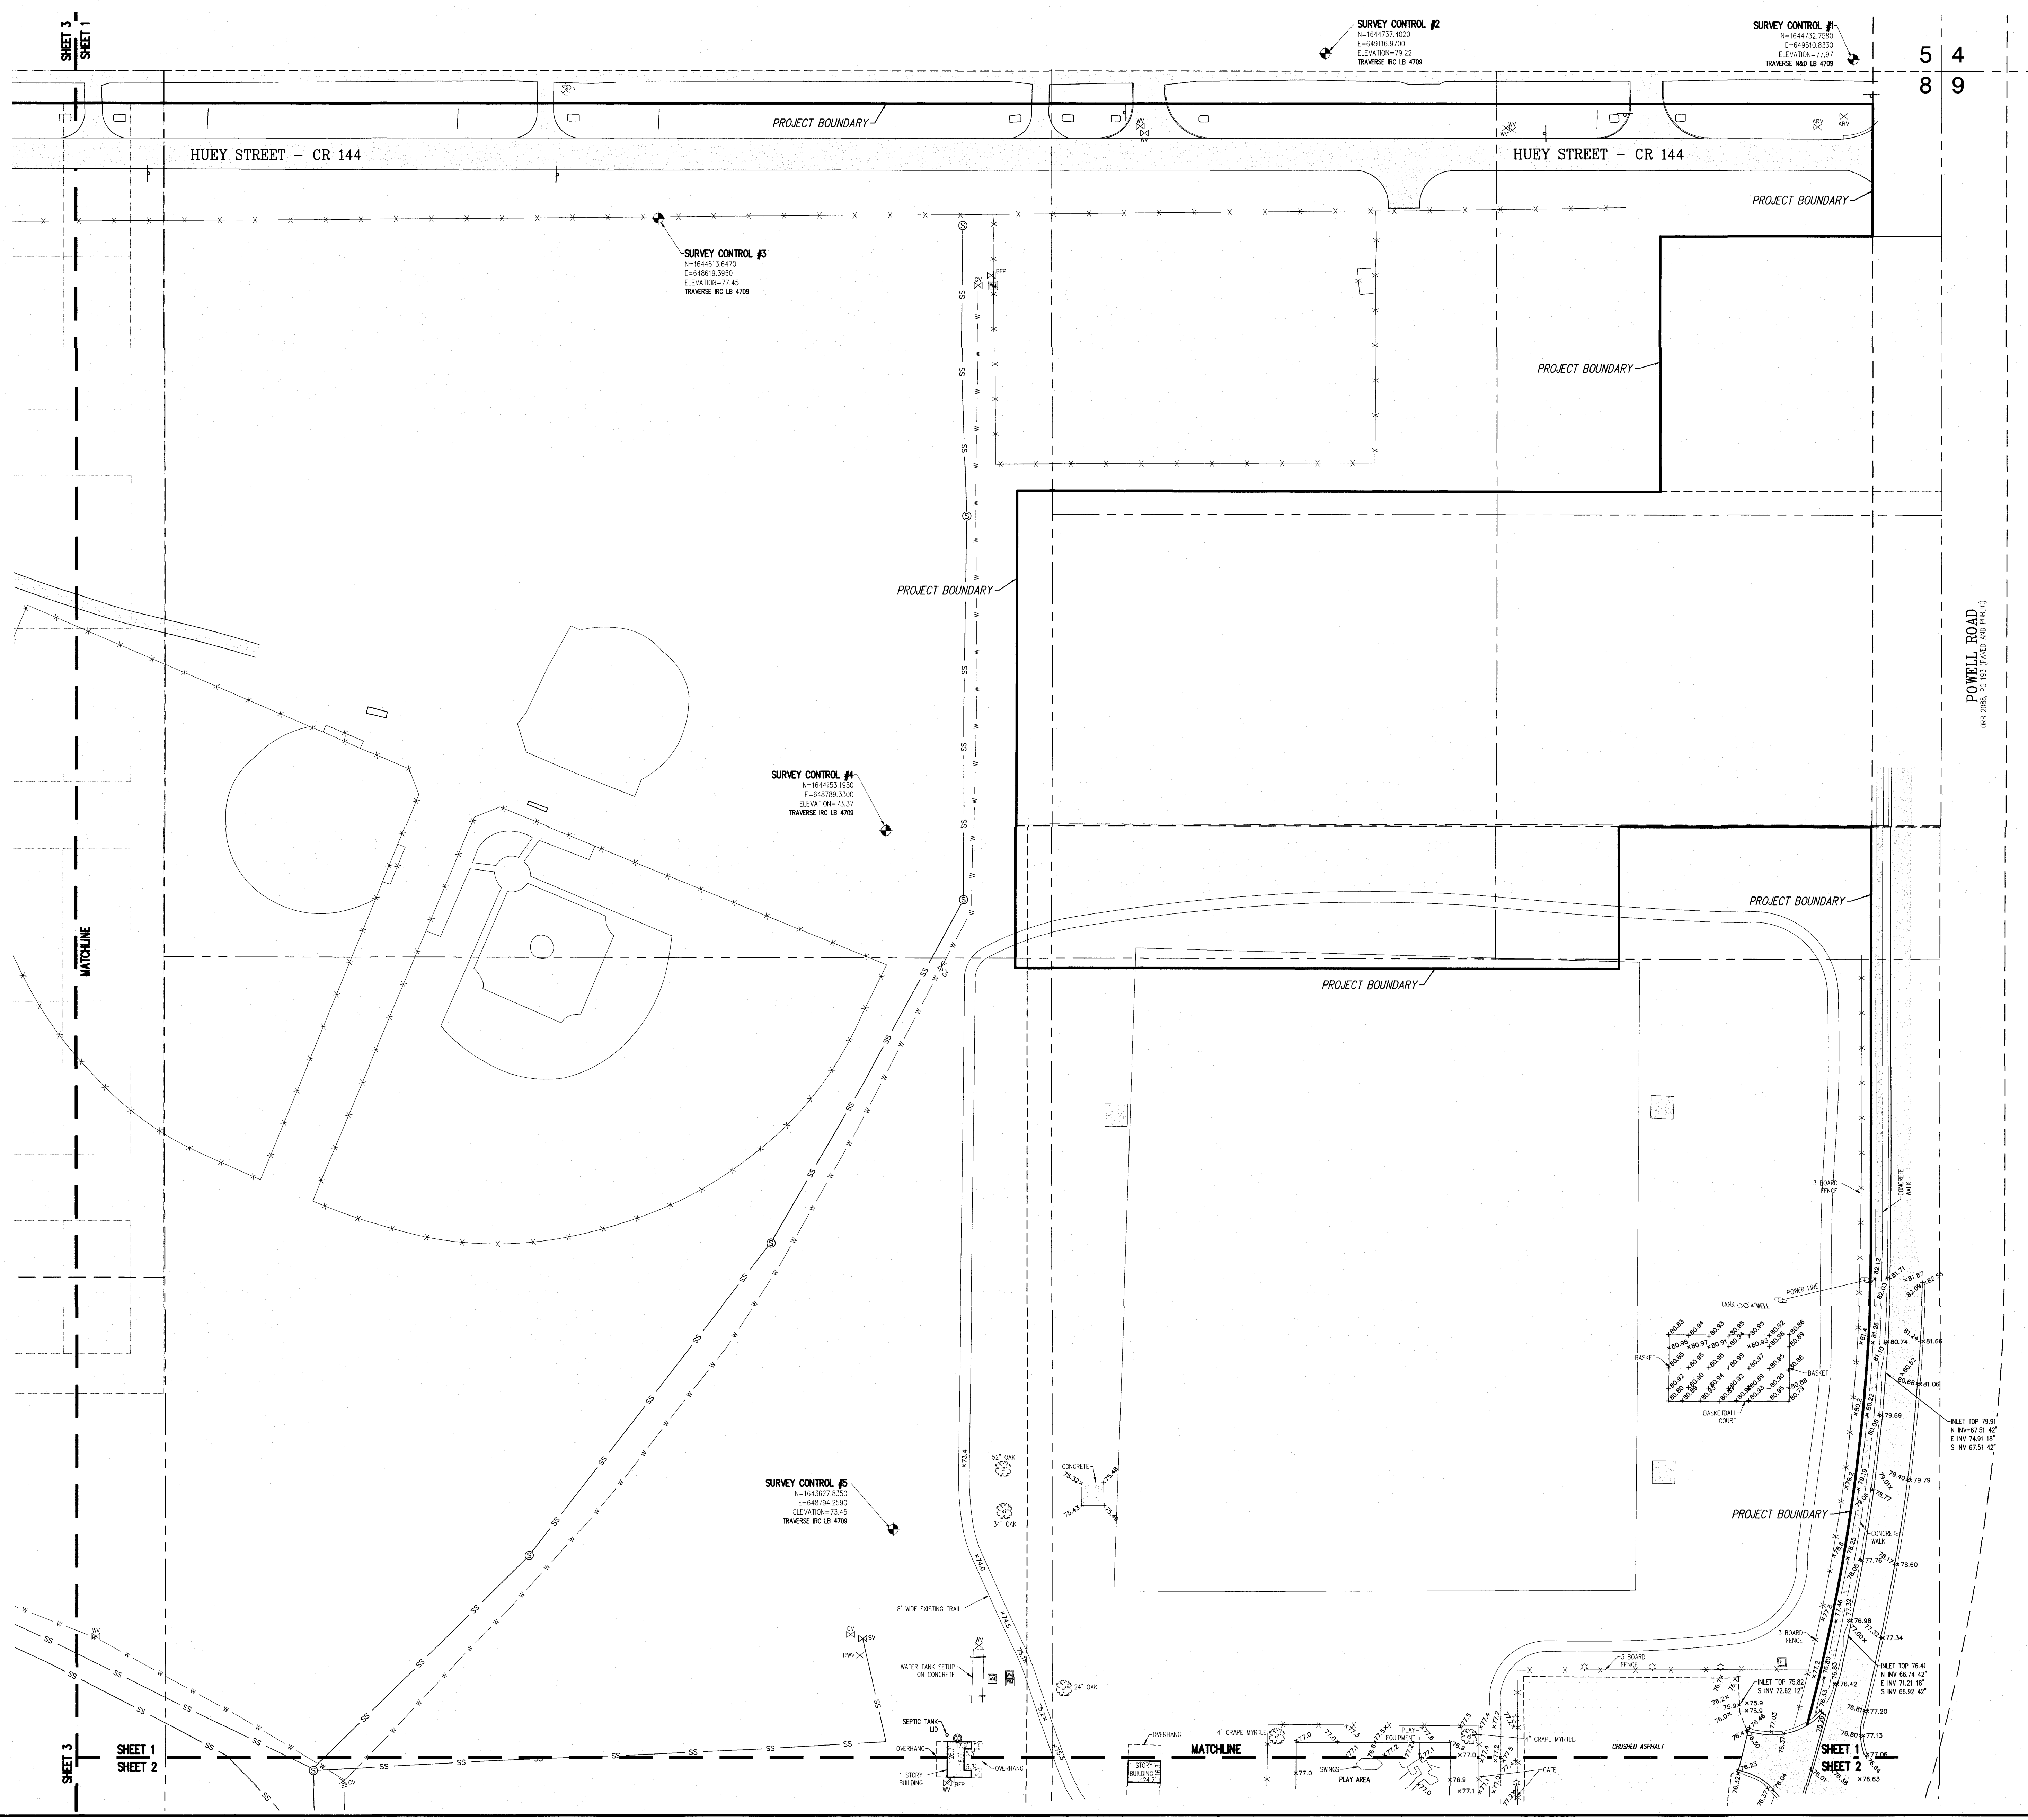

- NOTES:**
1. THE SURVEY MAP AND REPORT OR THE COPIES THEREOF ARE NOT VALID WITHOUT THE ORIGINAL SIGNATURE AND SEAL OF A FLORIDA LICENSED SURVEYOR AND MAPPER.
 2. THIS IS NOT A BOUNDARY SURVEY.
 3. HORIZONTAL DATUM IS FLORIDA STATE PLANE COORDINATE WEST ZONE.
 4. THIS SURVEY MEETS ALL APPLICABLE REQUIREMENTS OF THE FLORIDA STANDARDS OF PRACTICE AS CONTAINED IN RULE 5A-17.052 OF THE FLORIDA ADMINISTRATIVE CODE.
 5. ELEVATIONS ARE NORTH AMERICAN VERTICAL DATUM OF 1988 AND THIS SURVEY WAS BASED ON NGS STATION 23135 A (WITH AN ELEVATION OF 83.03) NAVD 88.

LEGEND


CM	INDICATES CONCRETE MONUMENT
MS	INDICATES METERS END SECTION
WLD	INDICATES SPOT ELEVATION
RC	INDICATES 2" OR 4" IRON ROD AND CAP
-SS-	INDICATES UNDERGROUND SANITARY LINE
W	INDICATES UNDERGROUND WATER LINE
PM	INDICATES PROFESSIONAL SURVEYOR AND MAPPER
PLS	INDICATES PROFESSIONAL LAND SURVEYOR
LB	INDICATES LICENSED BUSINESS
OR	INDICATES OFFICIAL RECORD BOOK
R/W	INDICATES RIGHT-OF-WAY
UL	INDICATES UNDERGROUND UTILITY LINE
UT	INDICATES UTILITY POLE
AM	INDICATES AIR RELEASE VALVE
EM	INDICATES ELECTRICAL RISER
TR	INDICATES TELEPHONE RISER
WM	INDICATES WATER METER
FR	INDICATES FIRE HYDRANT
CL	INDICATES CLEANOUT
BP	INDICATES BACKFLOW PREVENTER
GV	INDICATES GATE VALVE
ICV	INDICATES IRRIGATION CONTROL VALVE
SV	INDICATES SANITARY VALVE
SM	INDICATES SANITARY MANHOLE
EM	INDICATES ELECTRIC METER
CM	INDICATES CABLE TV RISER
RM	INDICATES RECLAIM WATER VALVE
AR	INDICATES AIR RELEASE VALVE

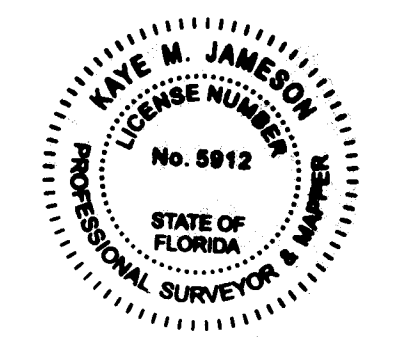


8/5/22
DATE
Kaye M. Jameson
KAYE M. JAMESON, PROFESSIONAL SURVEYOR & MAPPER
FLORIDA REGISTRATION NO. 5912

SPECIFIC PURPOSE SURVEY FOR CITY OF WILDWOOD
MILLENNIUM PARK SECTION 8, RANGE 23 EAST
TOWNSHIP 19 SOUTH, RANGE 23 EAST
SUNCOAST COUNTY, FLORIDA
SHEET 1 OF 3

SPECIFIC PURPOSE SURVEY

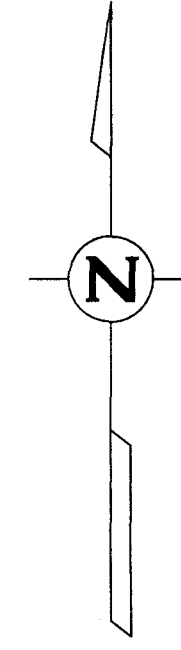


SCALE IN FEET
1" = 50'

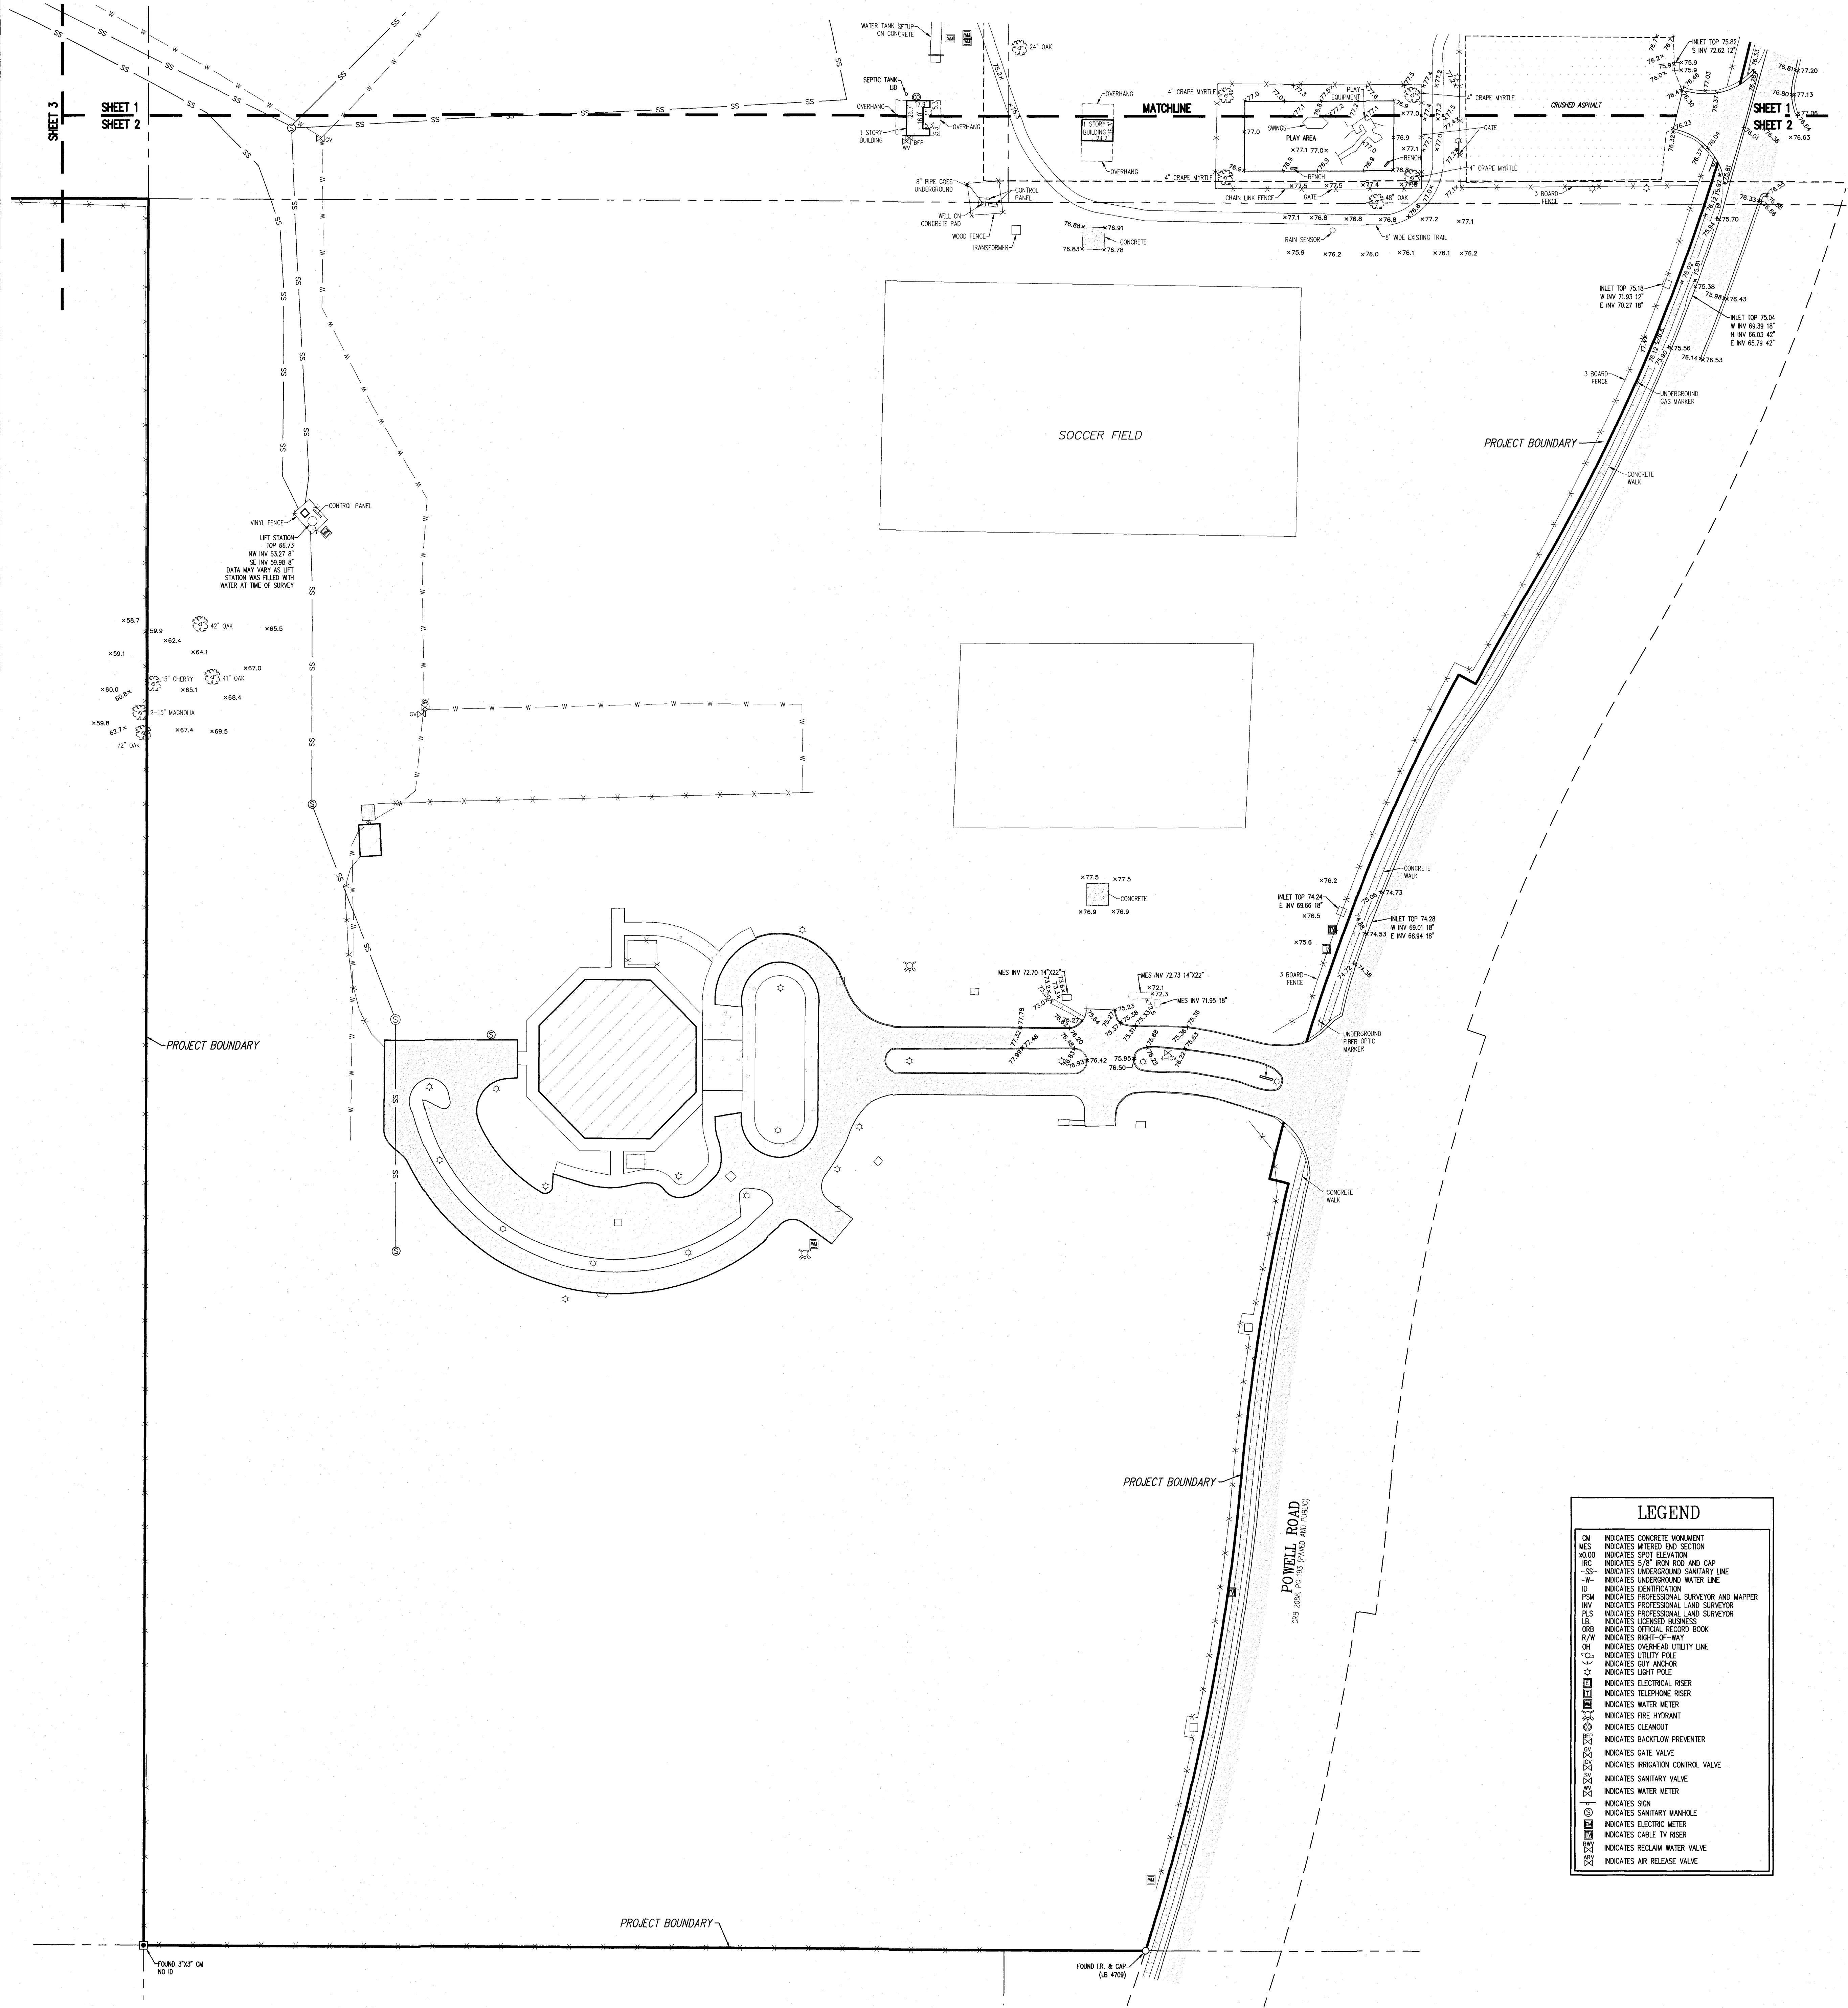

LEGEND	
OK	INDICATES CONCRETE MONUMENT
MES	INDICATES METERED D&O SECTION
ALSO	INDICATES SPOT ELEVATION
IR	INDICATES 5/8" IRON ROD AND CAP
U-1	INDICATES UNDERGROUND SANITARY LINE
U-2	INDICATES UNDERGROUND WATER LINE
ID	INDICATES IDENTIFICATION
PSM	INDICATES PROFESSIONAL SURVEYOR AND MAPPER
PLS	INDICATES PROFESSIONAL LAND SURVEYOR
PLB	INDICATES LICENSED BUSINESS
ORB	INDICATES OFFICIAL RECORD BOOK
R/W	INDICATES RIGHT-OF-WAY
OH	INDICATES OVERHEAD UTILITY LINE
U	INDICATES UTILITY POLE
U-1	INDICATES 5/8" ANCHOR
U-2	INDICATES LIGHT POLE
U-3	INDICATES ELECTRICAL RISER
U-4	INDICATES TELEPHONE RISER
U-5	INDICATES WATER METER
U-6	INDICATES FIRE HYDRANT
U-7	INDICATES CLEANDOUT
U-8	INDICATES BACKFLOW PREVENTER
U-9	INDICATES GATE VALVE
U-10	INDICATES IRRIGATION CONTROL VALVE
U-11	INDICATES SANITARY VALVE
U-12	INDICATES WATER METER
U-13	INDICATES SON
U-14	INDICATES SANITARY MANHOLE
U-15	INDICATES ELECTRIC METER
U-16	INDICATES CABLE TV RISER
U-17	INDICATES RECLAIM WATER VALVE
U-18	INDICATES AIR RELEASE VALVE




SPECIFIC PURPOSE SURVEY

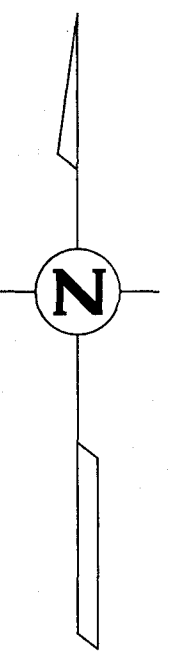

40 20 0 40 80 120
SCALE IN FEET
1" = 40'

SHEET 3
SHEET 1

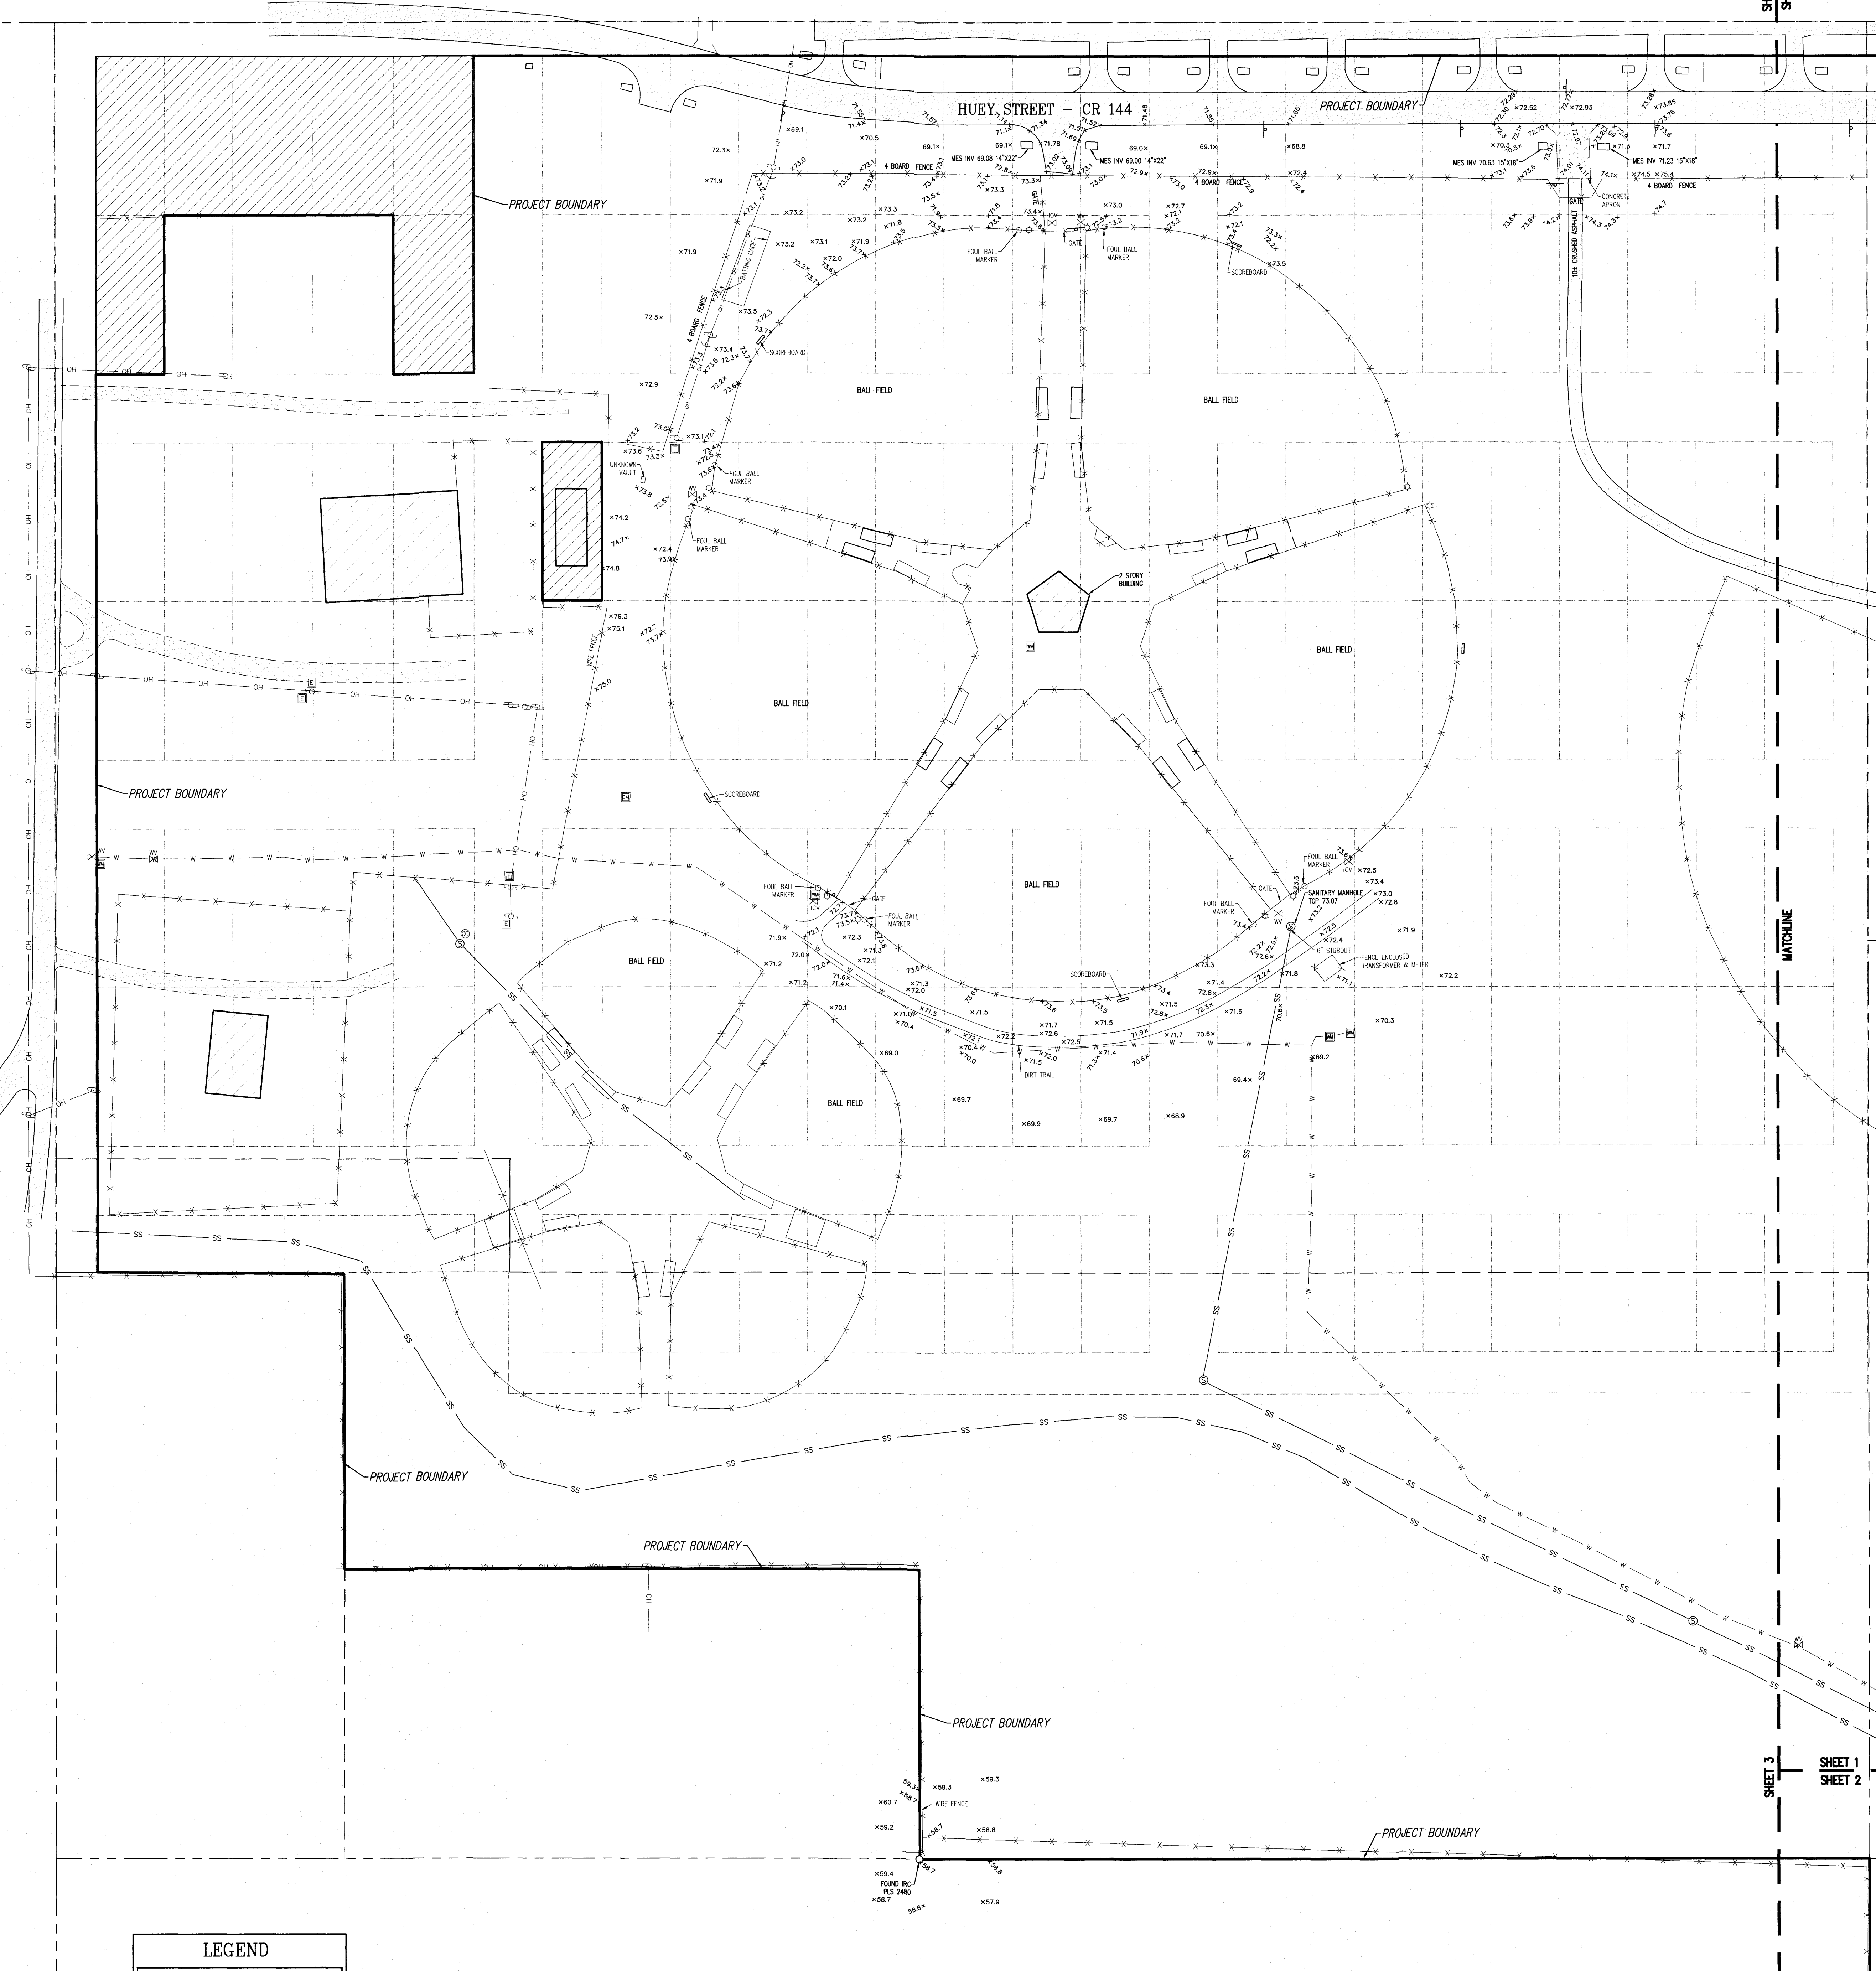

SHEET 3
SHEET 2

LEGEND

- CM INDICATES CONCRETE MONUMENT
- MES INDICATES METEDED END SECTION
- ADSD INDICATES SPOT ELEVATION
- IRC INDICATES 3/4" IRON ROD AND CAP
- SS- INDICATES UNDERGROUND SANITARY LINE
- W- INDICATES UNDERGROUND WATER LINE
- INDICATES IDENTIFICATION
- PSM INDICATES PROFESSIONAL SURVEYOR AND MAPPER
- PLS INDICATES PROFESSIONAL LAND SURVEYOR
- PLS INDICATES PROFESSIONAL LAND SURVEYOR
- LSB INDICATES LICENSED BUSINESS
- ORB INDICATES OFFICIAL RECORD BOOK
- R/W INDICATES RIGHT-OF-WAY
- INDICATES OVERHEAD UTILITY LINE
- INDICATES UTILITY POLE
- INDICATES STAY ANCHOR
- INDICATES LIGHT POLE
- INDICATES ELECTRICAL RISER
- INDICATES TELEPHONE RISER
- INDICATES WATER METER
- INDICATES FIRE HYDRANT
- INDICATES CLEANOUT
- INDICATES BACKFLOW PREVENTER
- INDICATES GATE VALVE
- INDICATES BREAKDOWN CONTROL VALVE
- INDICATES SANITARY VALVE
- INDICATES SANITARY VALVE
- INDICATES WATER METER
- INDICATES SON
- INDICATES SANITARY MANHOLE
- INDICATES ELECTRIC METER
- INDICATES CABLE TV RISER
- INDICATES RECLAIM WATER VALVE
- INDICATES AIR RELEASE VALVE